


0 1 2 3 4 5 6 7 8 9 10 inches

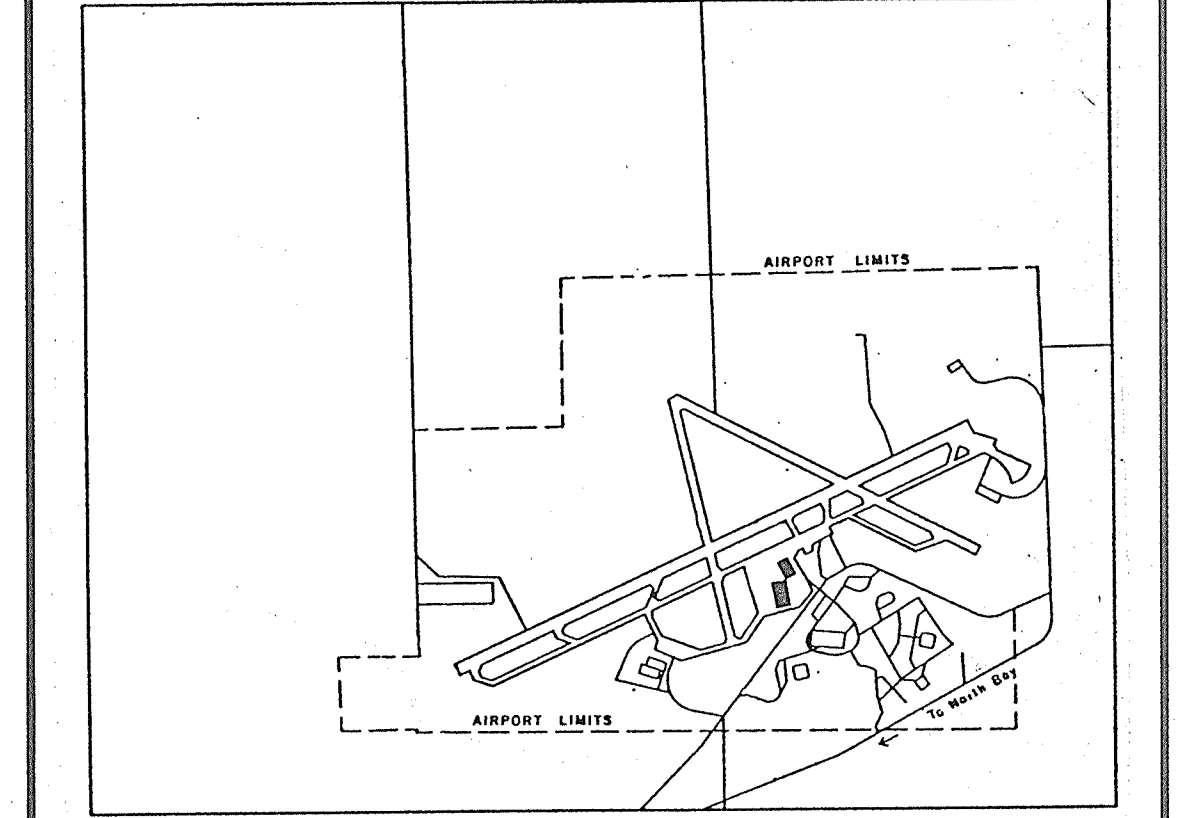

EXISTING	
FENCE LINE	X-X-X-X
TREE, WOODED AREA	(Symbol)
U.G. TANK	(Symbol)
DITCH	(Symbol)
CULVERT	(Symbol)
WATERMAIN	W (Symbol)
SANITARY SEWER	SA (Symbol)
STORM SEWER	ST (Symbol)
GASMAIN	G (Symbol)
P.V.C. PULLPIT	(Symbol)
PULLPIT	(Symbol)
CABLE DUCTS	(Symbol)
U.G. CABLE	(Symbol)
STREET SIGN	(Symbol)
ASPHALT SURFACE	(Symbol)
CONCRETE SURFACE	(Symbol)
CURB	(Symbol)
STREET LIGHT	(Symbol)
HYDRO POLE	H.P. (Symbol)
U.G. HYDRO CABLE	H (Symbol)
U.G. TELEPHONE CABLE	T (Symbol)
PROPOSED	
SANITARY SEWER & MANHOLE	M.H. 7 (Symbol)
WATERMAIN, VALVE, & HYDRANT SET	(Symbol)
VALVE CHAMBER, AIR RELEASE CH.	V.C. A.R.C. (Symbol)
EARTH PROBE - NO REFUSAL	(Symbol)
PROBE TO REFUSAL	(Symbol)
BOREHOLE	B.H. 8 (Symbol)

no.	by	date	approved	revisions
	par		approuvé	


Proctor & Redfern Limited
Consulting Engineers and Planners
Toronto North Bay

project title titre du projet
NORTH BAY AIRPORT
PART 'A'-CONNECT TO CITY WATER SUPPLY
PART 'B'-CONNECT TO CITY SAN. SEWER

drawing title titre du dessin
PLAN AND PROFILE OF SANITARY SEWER (AVIATION AVE. TO AVIATION LANE)

scale échelle	
AS SHOWN	
designed by R.A.B.	conçu par
drawn by D.J.F. - A.E.R.	dessiné par
approved by <i>CSB</i>	approuvé par
project date MAY 16, 1986	date du projet
project no. S10135-1045	projet no.
reference 8459	référence
sheet C-7	feuille
of 11	de

01350642C010

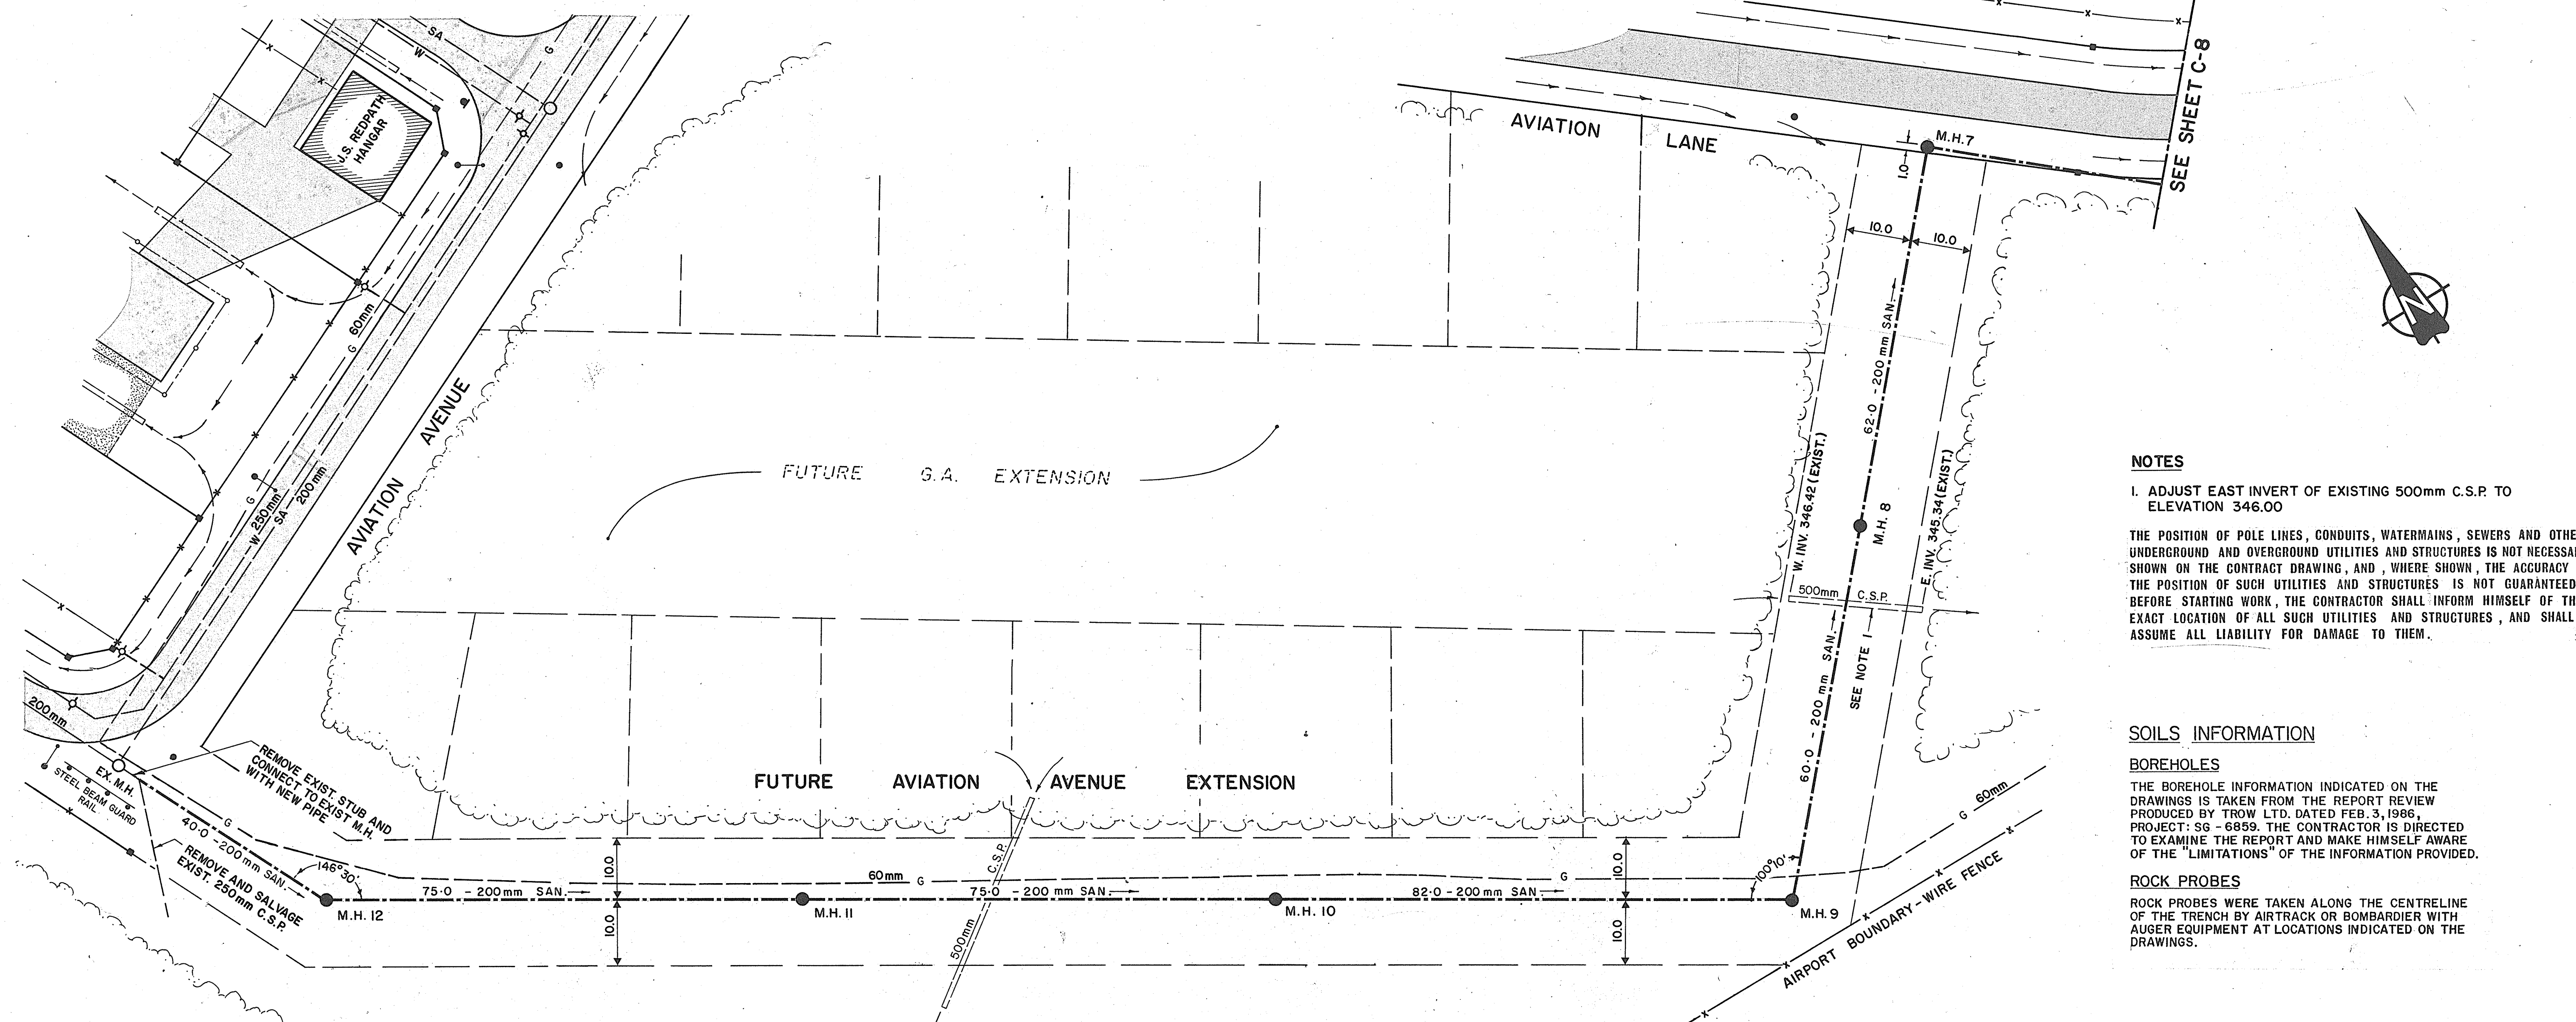

NOTES
1. ADJUST EAST INVERT OF EXISTING 500mm C.S.P. TO ELEVATION 346.00

THE POSITION OF POLE LINES, CONDUITS, WATERMANS, SEWERS AND OTHER UNDERGROUND AND OVERGROUND UTILITIES AND STRUCTURES IS NOT NECESSARILY SHOWN ON THE CONTRACT DRAWING, AND, WHERE SHOWN, THE ACCURACY OF THE POSITION OF SUCH UTILITIES AND STRUCTURES IS NOT GUARANTEED. BEFORE STARTING WORK, THE CONTRACTOR SHALL INFORM HIMSELF OF THE EXACT LOCATION OF ALL SUCH UTILITIES AND STRUCTURES, AND SHALL ASSUME ALL LIABILITY FOR DAMAGE TO THEM.

SOILS INFORMATION
BOREHOLES
THE BOREHOLE INFORMATION INDICATED ON THE DRAWINGS IS TAKEN FROM THE REPORT REVIEW PRODUCED BY TROW LTD. DATED FEB. 3, 1986, PROJECT: 88-6889. THE CONTRACTOR IS DIRECTED TO EXAMINE THE REPORT AND MAKE HIMSELF AWARE OF THE "LIMITATIONS" OF THE INFORMATION PROVIDED.
ROCK PROBES
ROCK PROBES WERE TAKEN ALONG THE CENTRELINE OF THE TRENCH BY AIRTRACK OR BOMBARDIER WITH AUGER EQUIPMENT AT LOCATIONS INDICATED ON THE DRAWINGS.

