
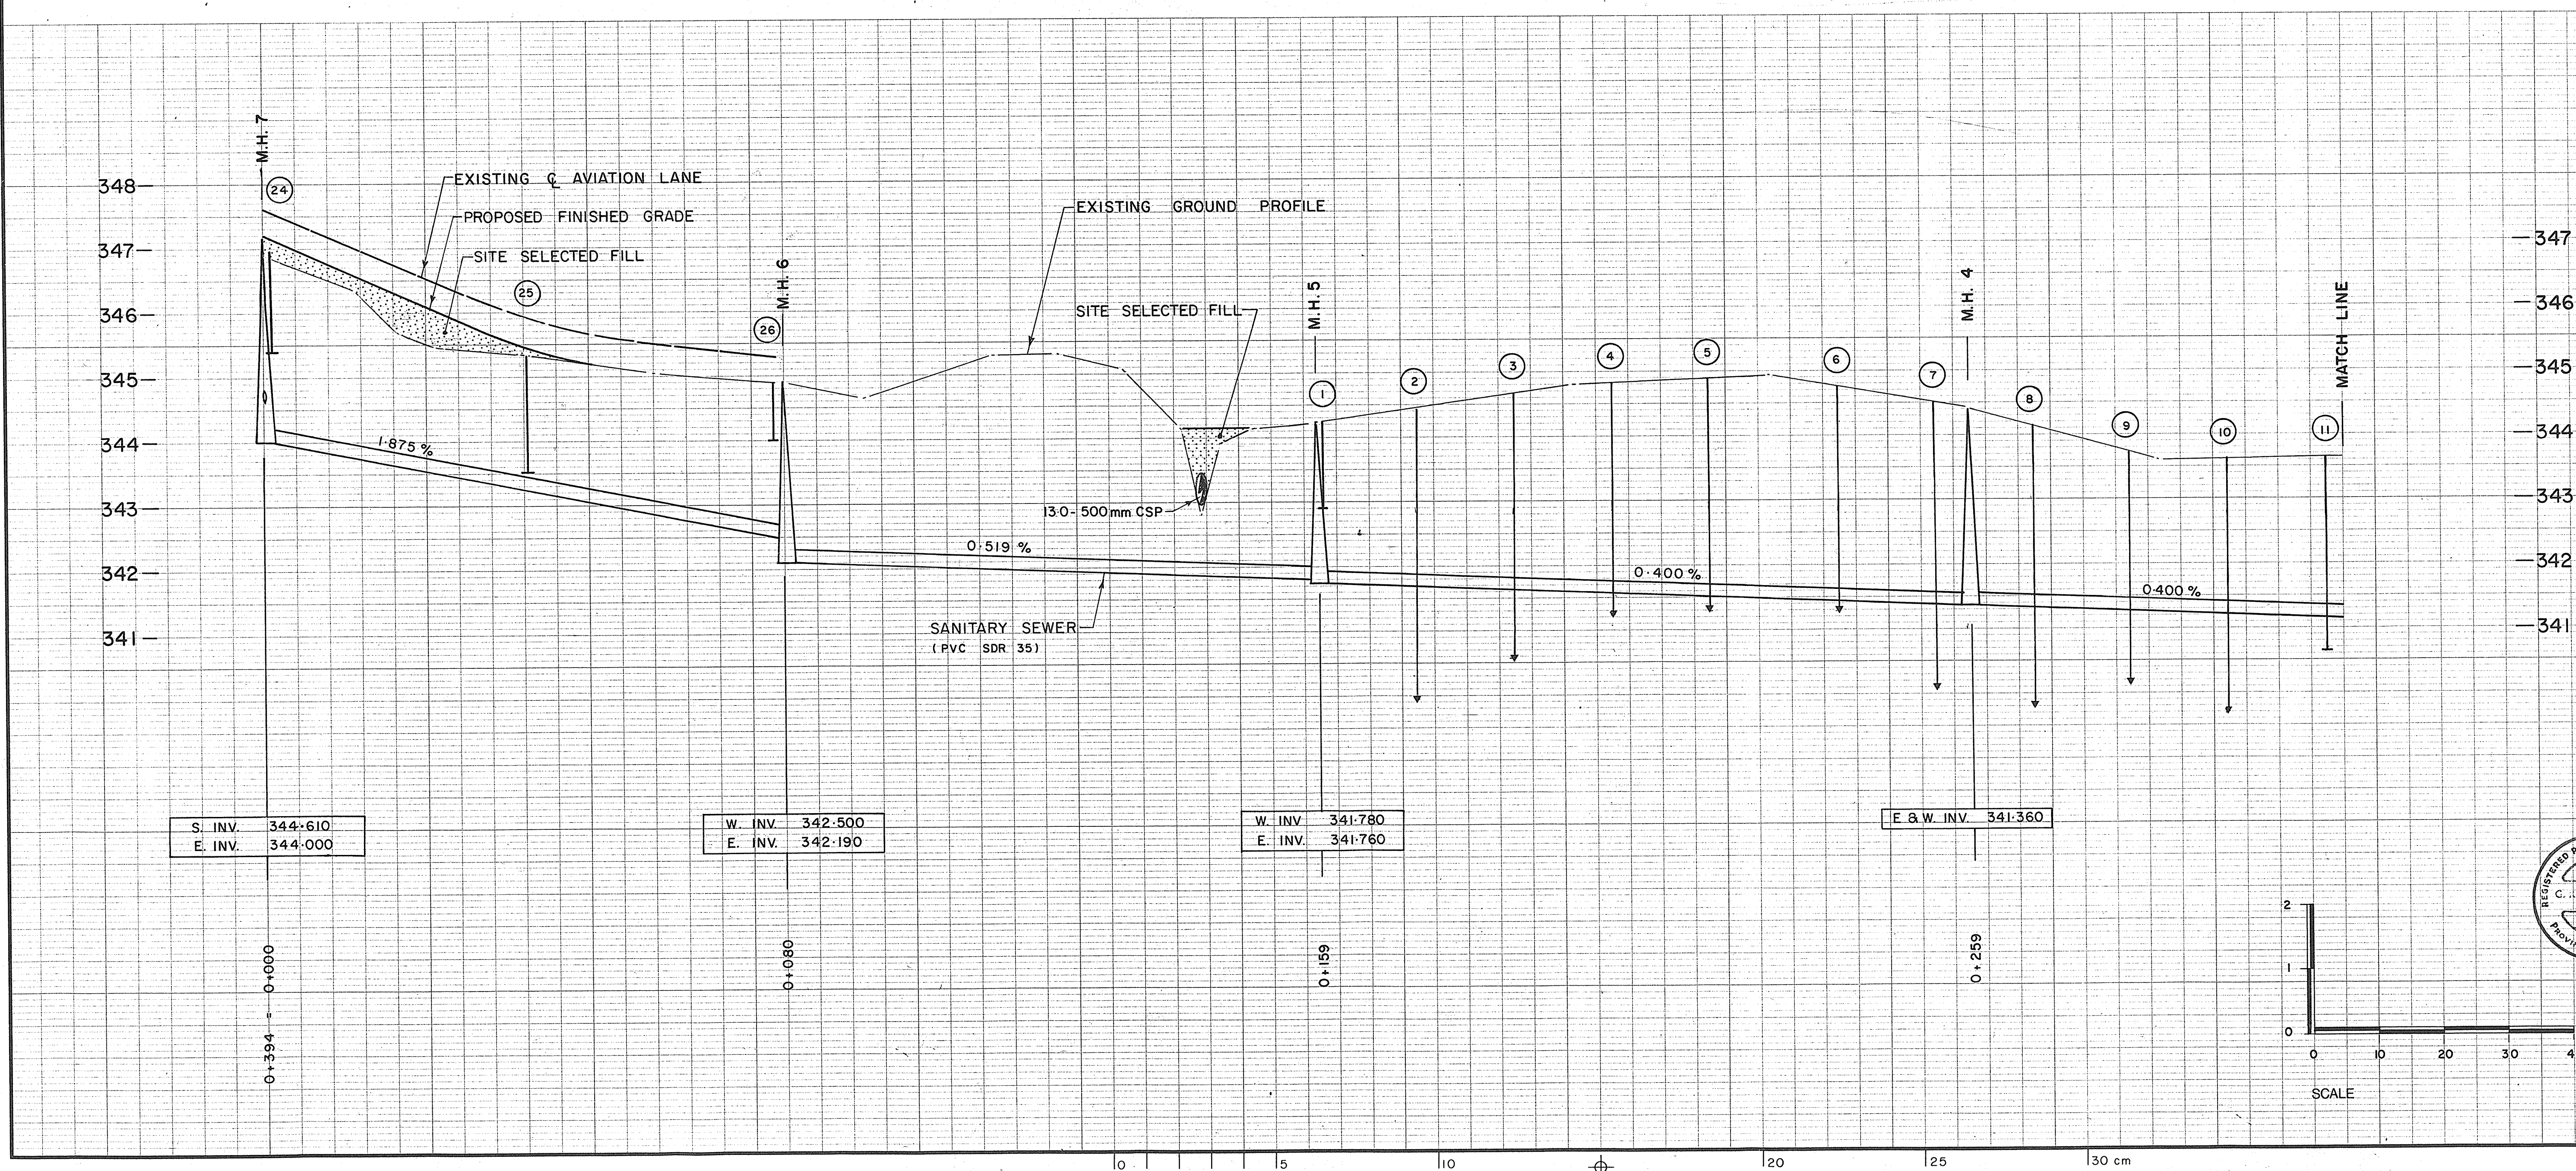


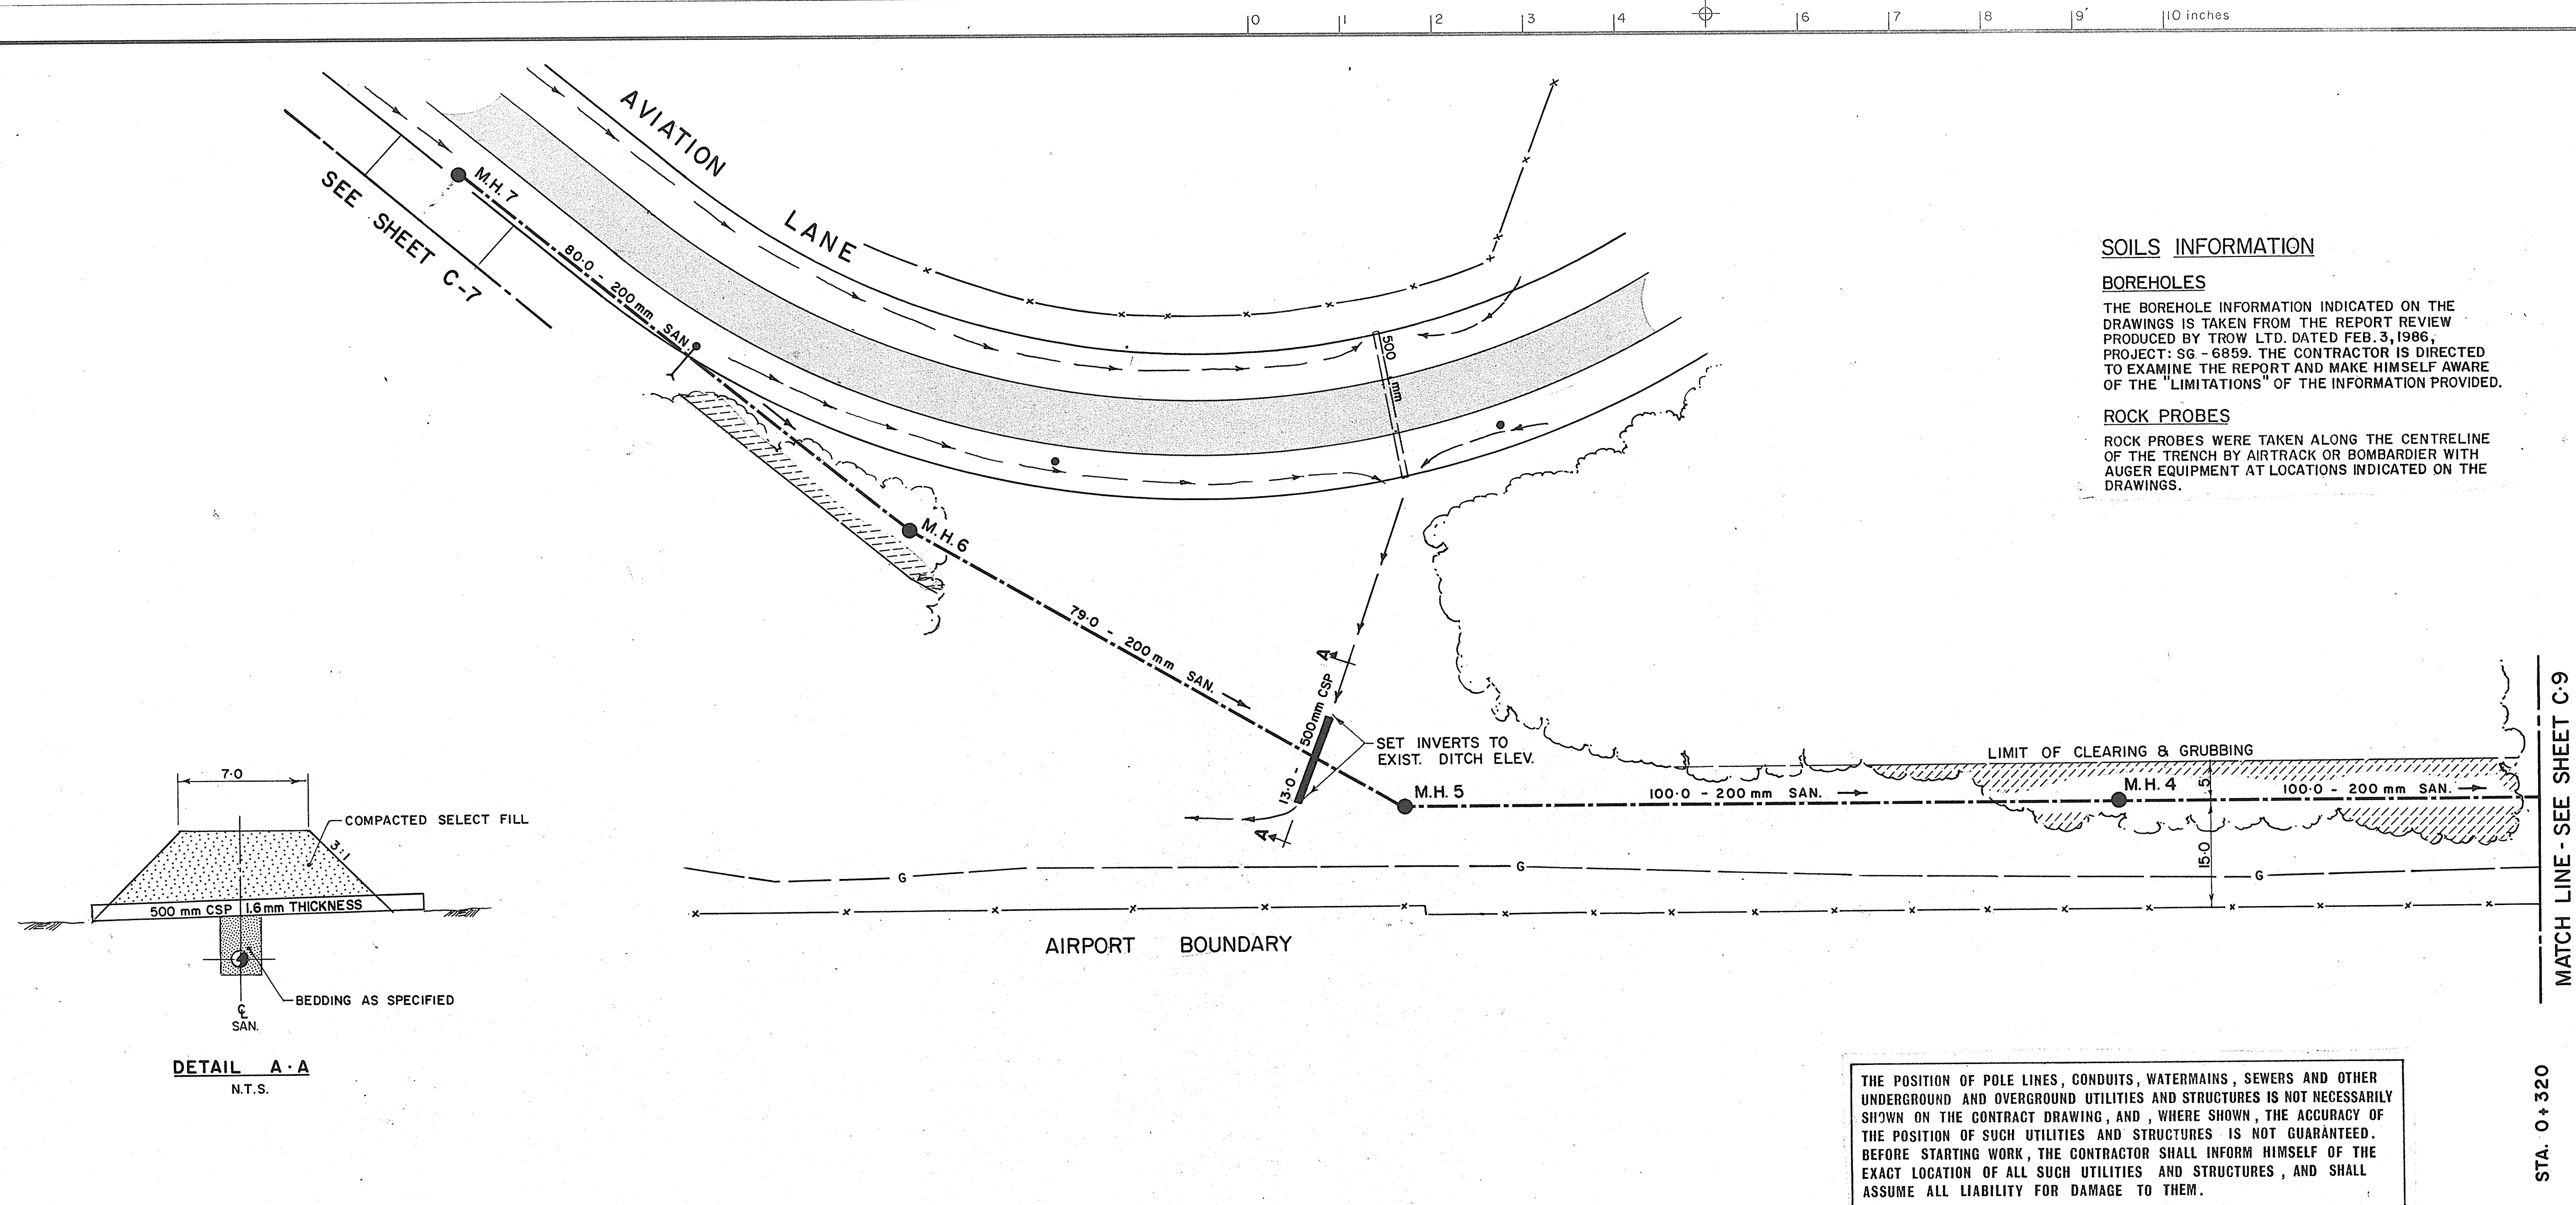

Transport Canada
Air

Transports Canada
Air

ENGINEERING & ARCHITECTURE
ONTARIO REGION

GÉNIE & ARCHITECTURE
RÉGION DE L'ONTARIO

location map
carte de location

legend
légende

EXISTING

- FENCE LINE
- TREE, WOODED AREA
- U.S. TANK
- DITCH
- CULVERT
- WATERMAIN
- SANITARY SEWER
- STORM SEWER
- GASMAIN
- P.V.C. PULLPIT
- PULLPIT
- CABLE DUCTS
- U.G. CABLE
- STREET SIGN
- ASPHALT SURFACE
- CONCRETE SURFACE
- CURB
- STREET LIGHT
- HYDRO POLE
- U.G. HYDRO CABLE
- U.G. TELEPHONE CABLE

PROPOSED

- SANITARY SEWER & MANHOLE
- WATERMAIN, VALVE, & HYDRANT SET
- VALVE CHAMBER, AIR RELEASE CH.
- EARTH PROBE - NO REFUSAL
- PROBE TO REFUSAL
- BOREHOLE

no.	by	date	approved	revisions

Proctor & Redfern Limited
Consulting Engineers and Planners
Toronto North Bay

project title
titre du projet
NORTH BAY AIRPORT

part 'A' - CONNECT TO CITY WATER SUPPLY
part 'B' - CONNECT TO CITY SAN. SEWER

drawing title
titre du dessin
PLAN AND PROFILE OF SANITARY SEWER (AVIATION LANE TO SOUTHERLY AIRPORT BOUNDARY)

scale
échelle
AS SHOWN

designed by conçu par	project date date du projet
R-A-B	MAY 16, 1986

drawn by dessiné par	project no. projet no.
D-J-F - A-E-R	S10135 - 1045

approved by approuvé par	reference référence
<i>[Signature]</i>	8459

sheet feuille	of de
C-8	11

01350642C011