


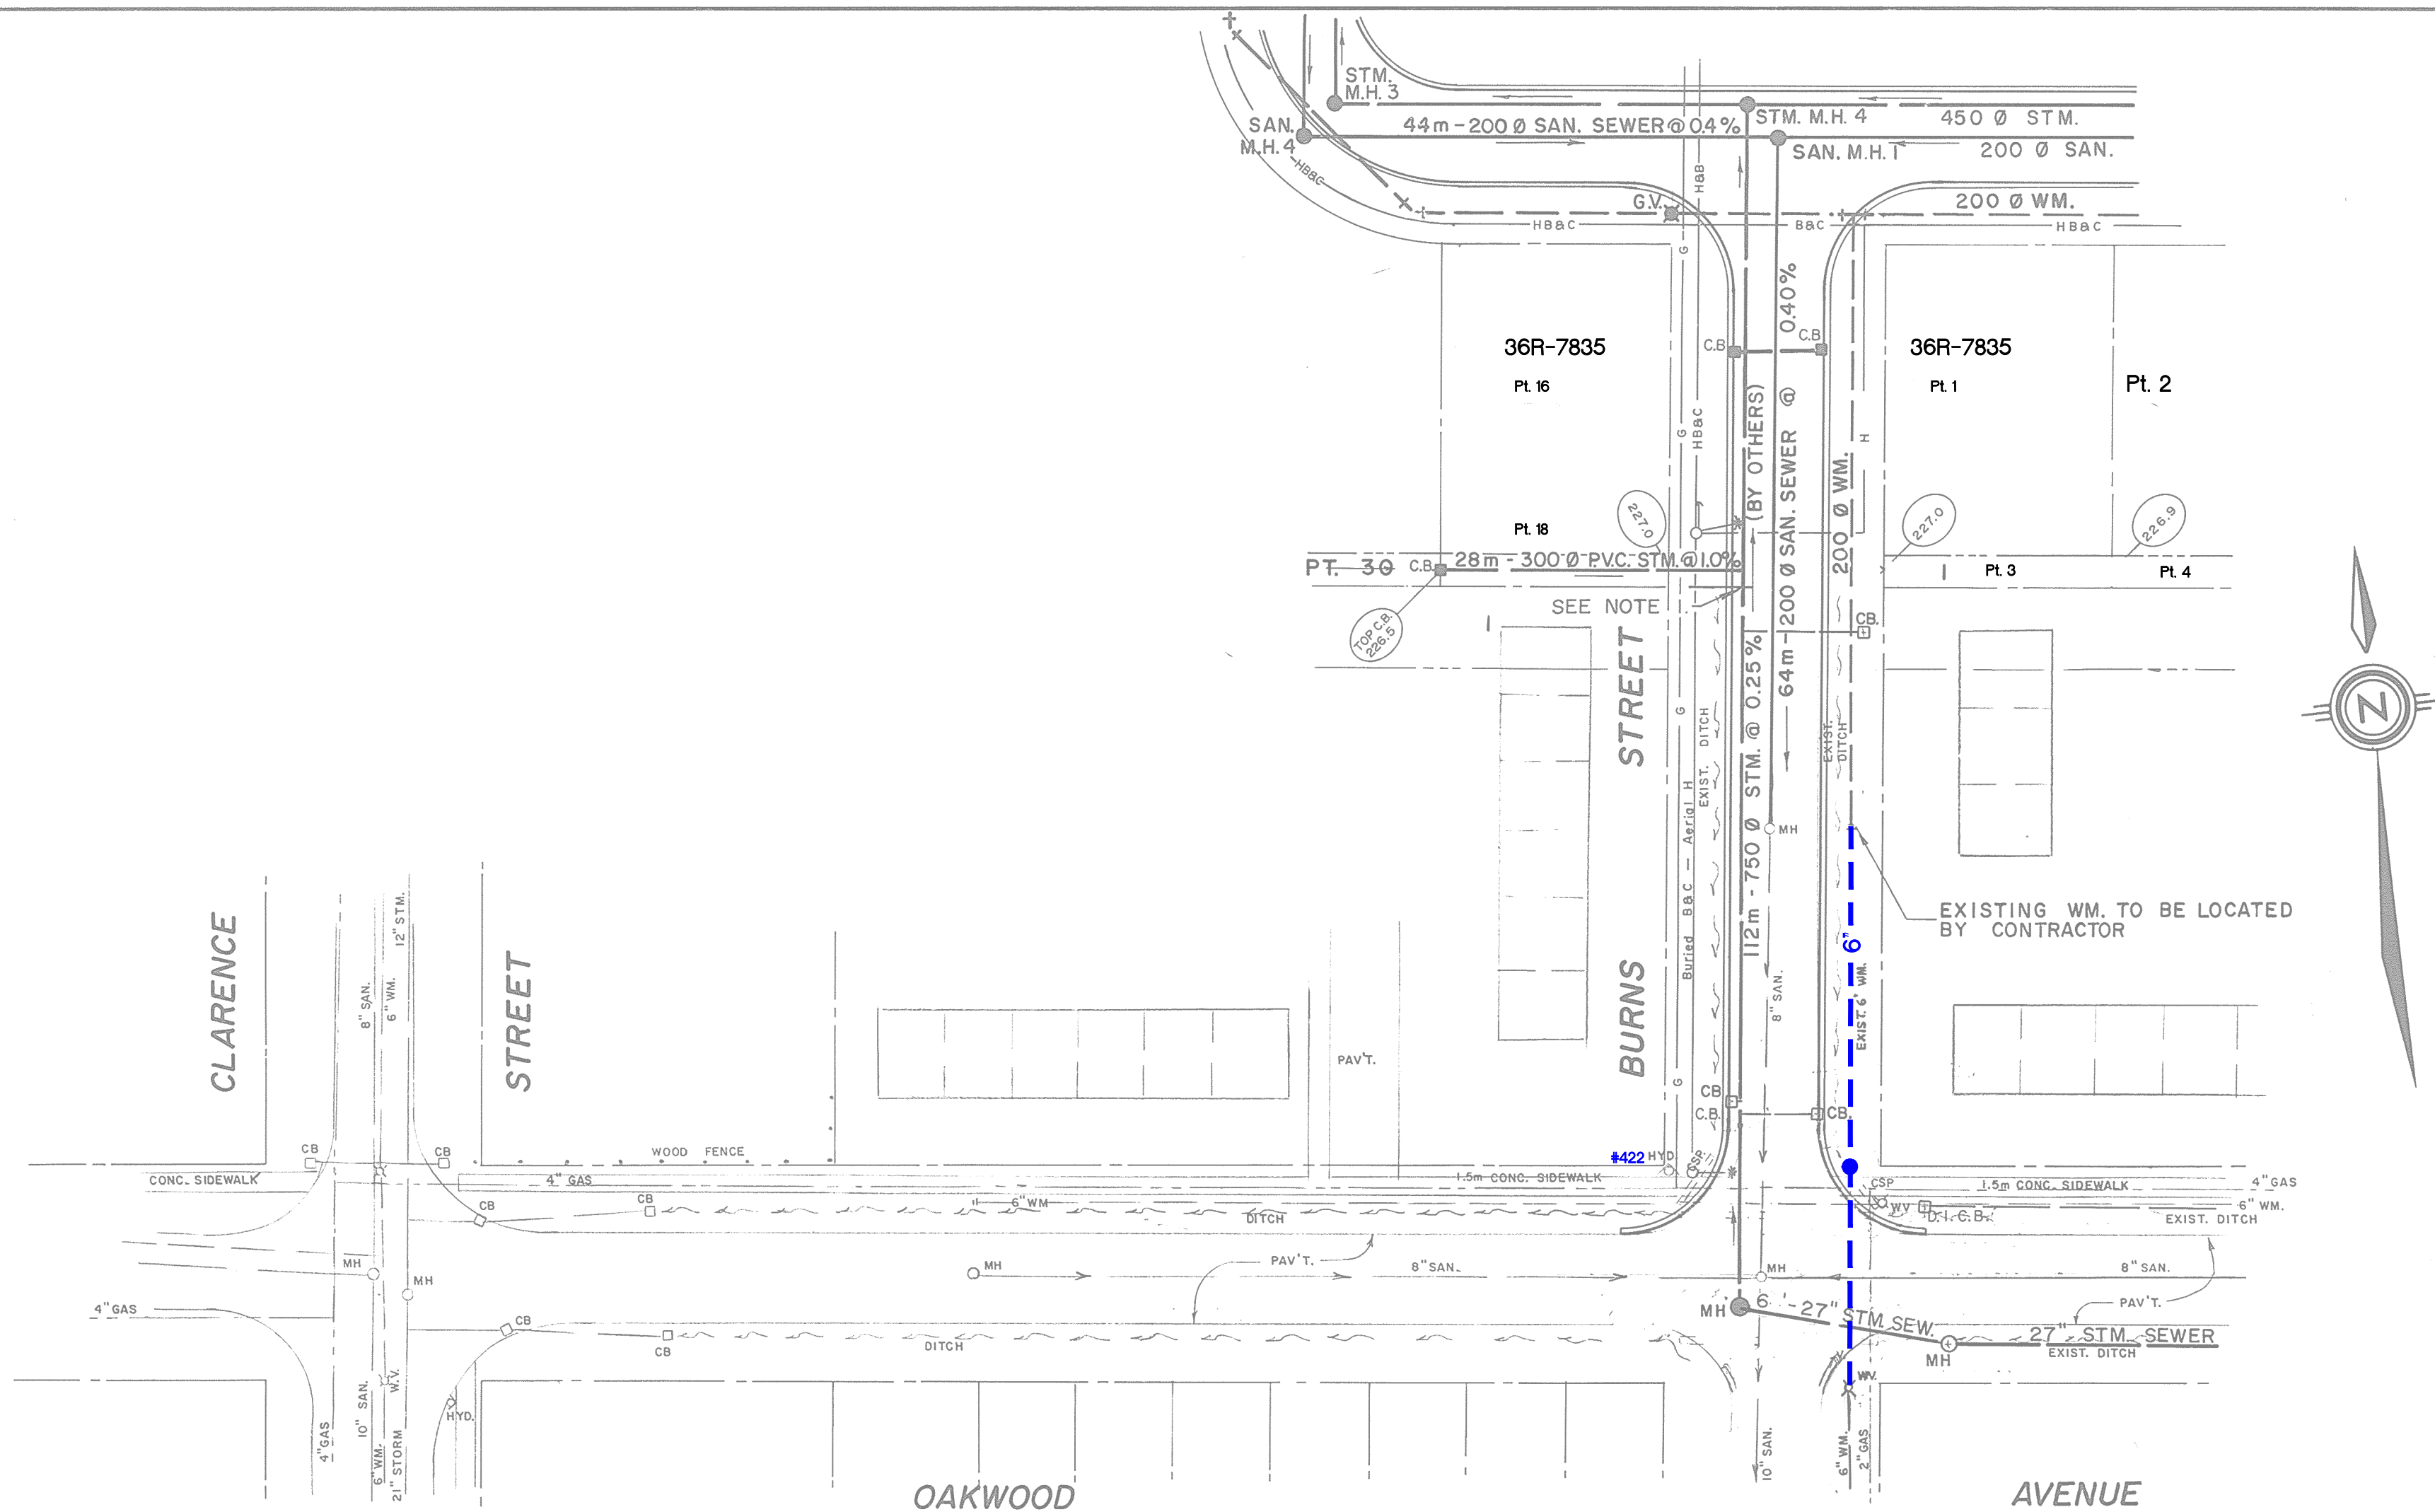

NOTES:
1. 750 DIA. STORM SEWER FROM M.H. 4 TO M.H. 7 AND INCLUDING M.H. 7, 2 CATCHBASINS AND 2 DITCHINLET CATCHBASINS AT OAKWOOD AVENUE INTERSECTION TO BE INSTALLED BY OTHERS PRIOR TO CONSTRUCTION OF CURBS AND PAVING ON BURNS STREET.



DISCLAIMER

The information contained on this drawing may be based upon data provided by others and may not have been verified by either as-constructed drawings or an Ontario Land Surveyor. The City of North Bay cannot accept responsibility for any errors or omissions on any information shown herein. Field verification, land surveys or excavation (with City approvals) may be required to determine actual location of any and all utilities or property lines.

GAS PLANT APPROVED <i>[Signature]</i> Northern & Central Gas Corp. Ltd. Date	CATV PLANT APPROVED <i>[Signature]</i> McLean - Hunter Cable T.V. Ltd. Date
HYDRO PLANT APPROVED <i>[Signature]</i> North Bay Hydro Date	BELL PLANT APPROVED <i>[Signature]</i> Bell Canada Ltd. Date

REVISIONS		
DATE	DETAILS	BY
Aug 07	6" Watermain Added	r.j.o.
Aug 07	Registered Plans Added.	r.j.o.
16/12/86	GATE VALVE LOCATION REVISED	P.L.C.

RECOMMENDED BY	APPROVED BY

NEW ERA HOMES LIMITED

COLUMBUS COURT
SUBDIVISION

PLAN AND PROFILE
BURNS STREET

NORTHLAND ENGINEERING LTD.

Consulting Engineers and Planners

NORTH BAY		SUDBURY	TIMMINS
DRAWN BY:	P.L. CHANDLER	DATE:	FEBRUARY, 1986
CHECKED BY:	M.B. BOTHWELL	FIELD BOOK:	
SCALE:	HORIZ. 1:500 VERT. 1:50	CONTRACT NO:	
OFFICE	NORTH BAY	PROJECT NO	2843
		DRAWING NO	B-178

