
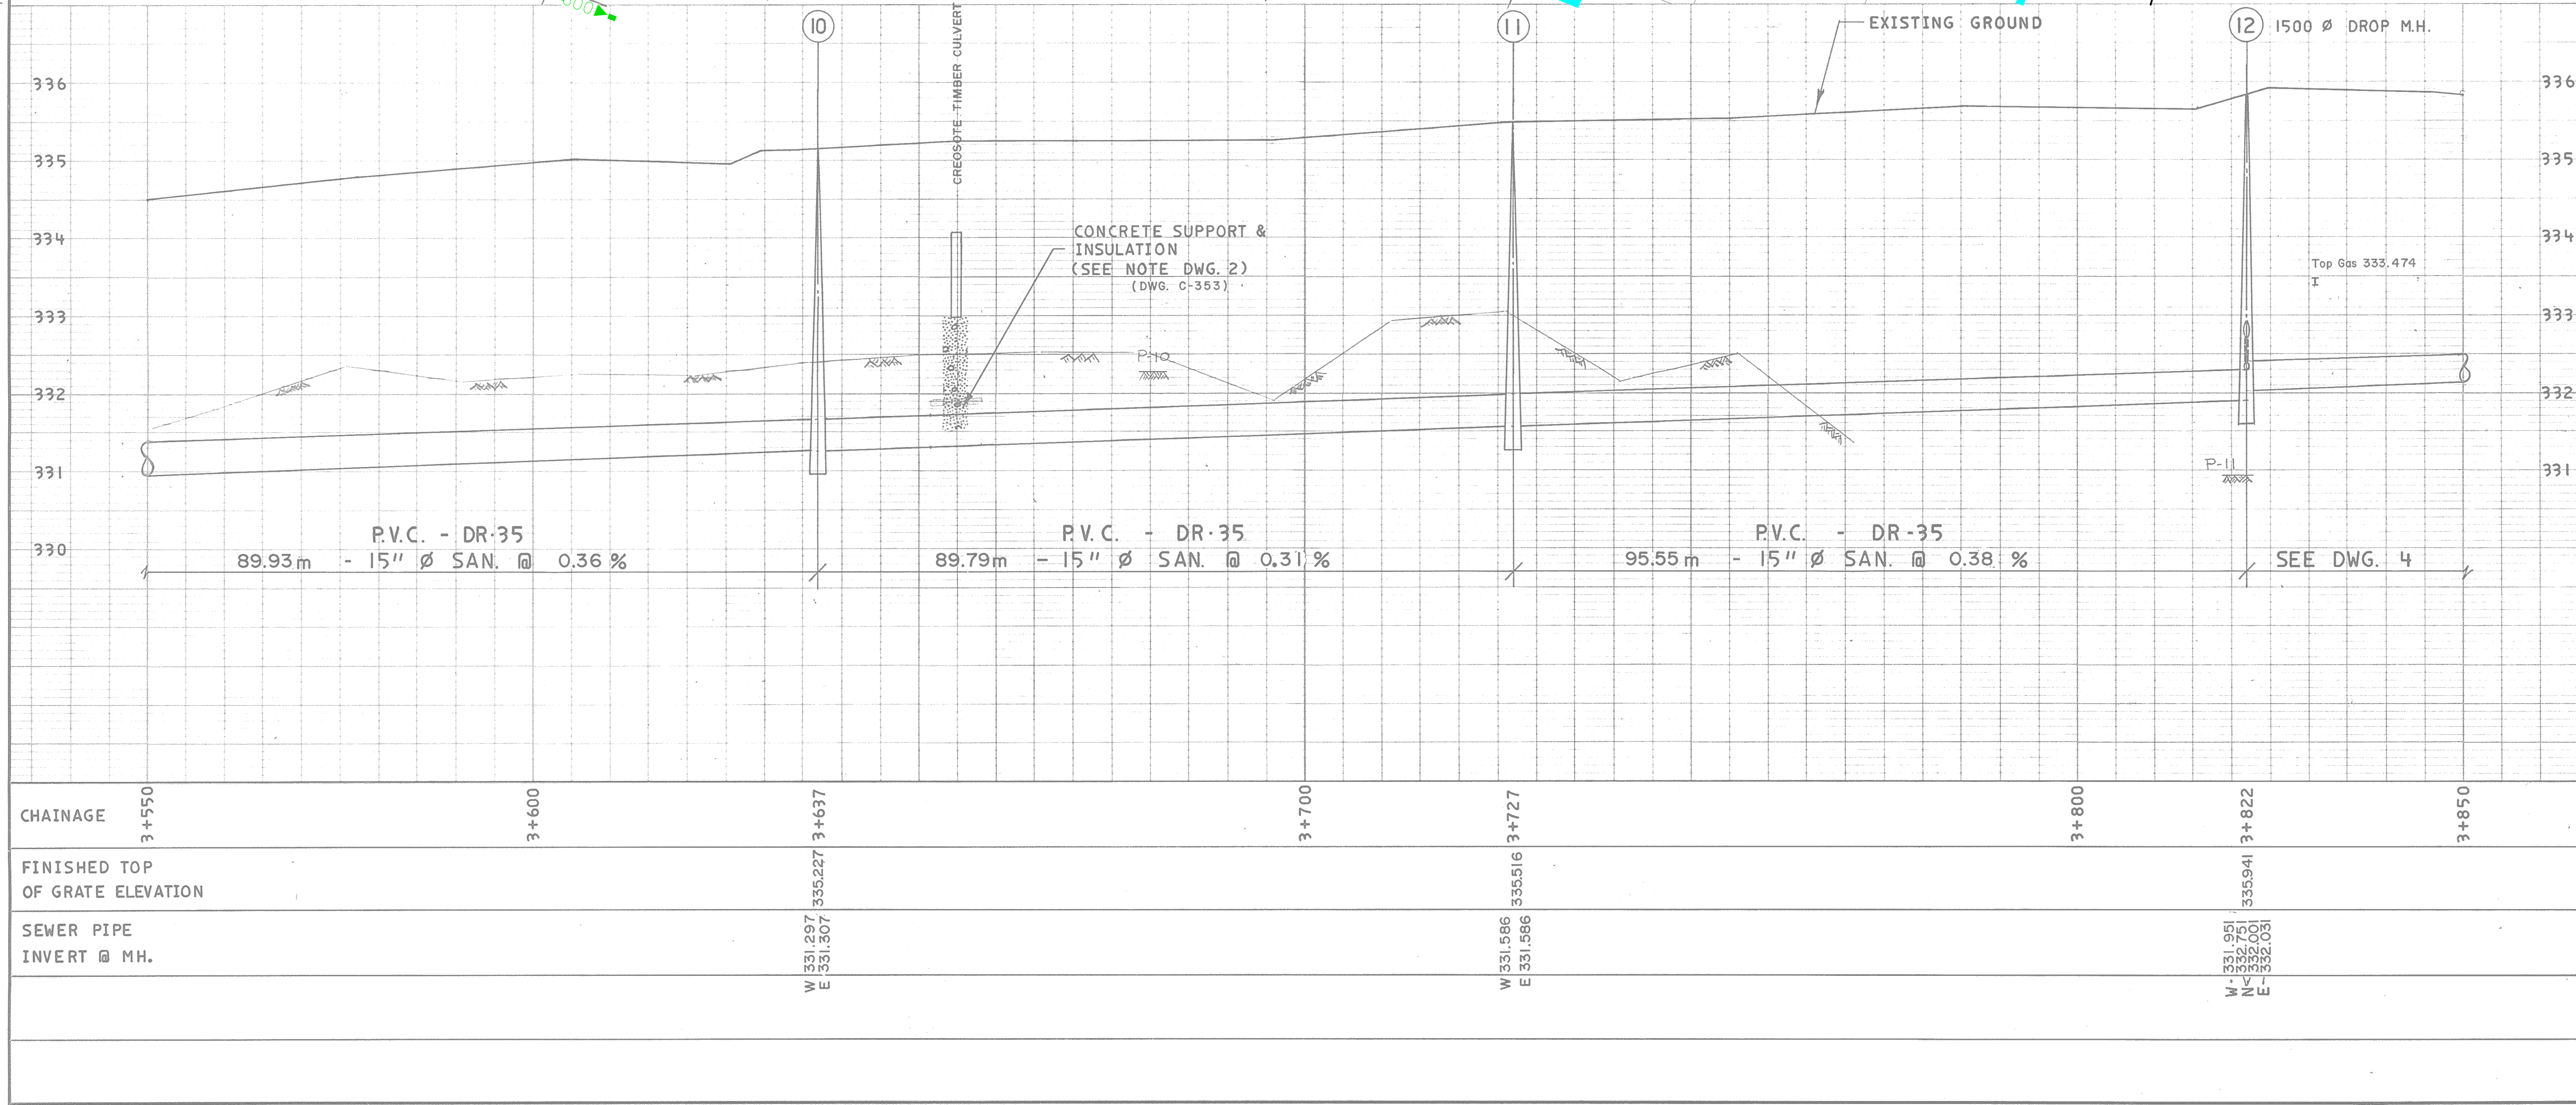


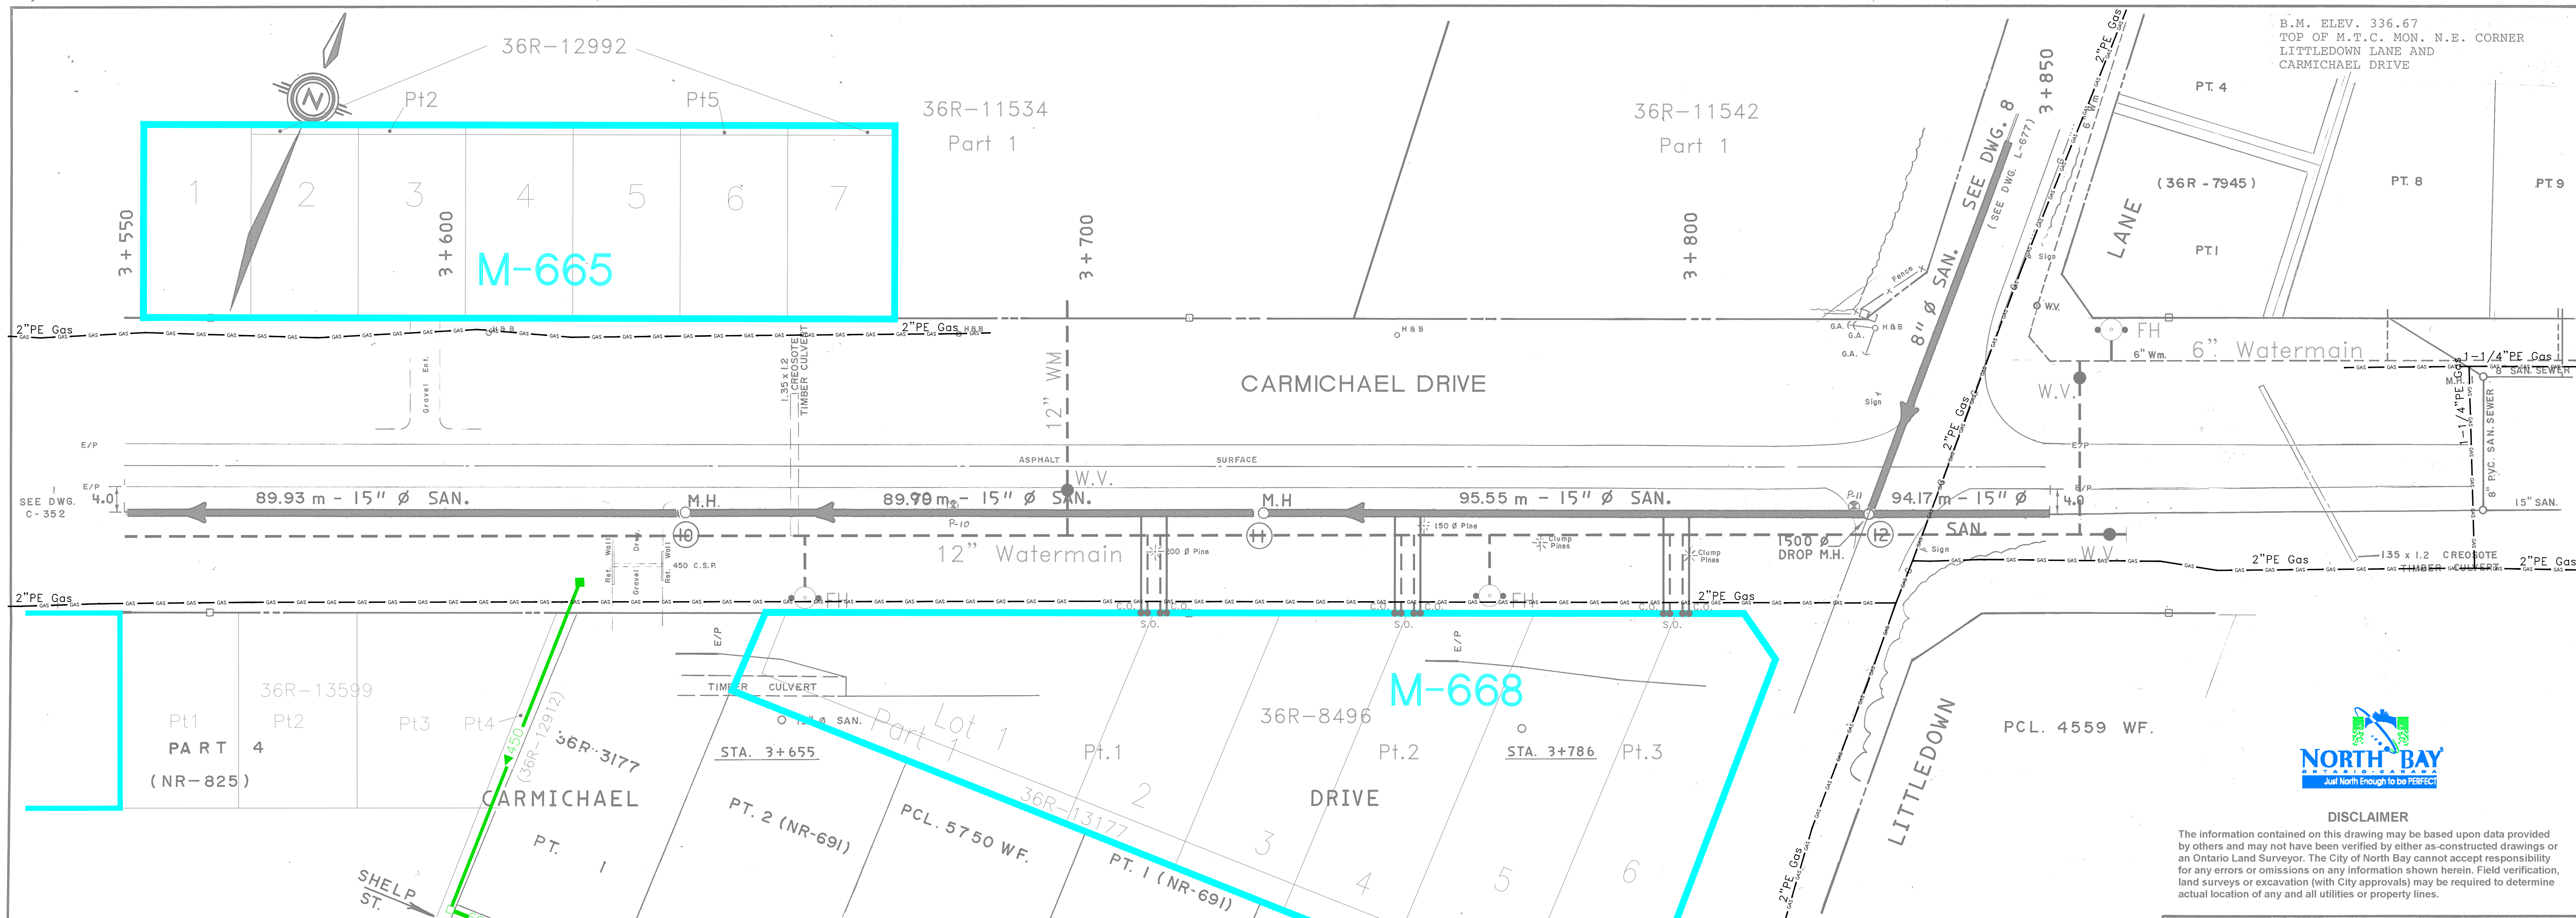

REVISIONS		
DATE	DETAILS	BY
8/11/84	B.M. DATA ADDED	P.L.C.
MAR. '87	AS CONST. SAN. SEWER CONT. 125-84 BK. 275	P.L.C.
FEB. '92	AS CONST. SAN. SEWER-W.M. AS C-354 'A'	R.T.
AUG. '09	12" WATERMAIN, HYDRANTS and VALVES (Approx.)	J.S.T.P.
Aug '10	Added 36R-12912	G.W.C.
Dec '10	Added 36M-665 + 36R-12992	G.W.C.
Jan '12	Added 36M-668 + 36R-13177	G.W.C.
May '14	Added 36R-13599	G.W.C.

RECOMMENDED BY	APPROVED BY
CITY OF NORTH BAY	
CARMICHAEL DRIVE TRUNK SEWER	
PLAN AND PROFILE STA. 3+550 TO STA. 3+850	
NORTHLAND ENGINEERING LTD.	
Consulting Engineers and Planners	
NORTH BAY	SUDBURY
DATE:	JULY 1984
DRAWN BY:	P. L. CHANDLER
CHECKED BY:	D. A. RICHARDS
SCALE:	1:500 HOR. 1:50 VERT.
CONTRACT NO.	
OFFICE	PROJECT NO.
N. BAY	2779
DRAWING NO.	C-353