



WATERMAINS - P.V.C. DR-18 C.S.A. CERTIFIED TO B.137.3
SHALL CONFORM TO A.W.W.A. C900 STANDARD.

(2") 50mm DIA. WATERLINE - IPEX "GOLD STRIPE" TUBING, CERTIFIED TO B.137.1
C/W COMPRESSION FITTINGS

SERVICES - SEAMLESS COPPER SHALL COMPLY WITH A.S.T.M. B-88. TYPE 'K'.

GRAVITY SEWERS - P.V.C. DR-35 CERTIFIED TO C.S.A. B.182.2 OR B182.4
AND CONFORM TO A.S.T.M. D3034 F679, F794 & F949.



SEALING GASKETS MUST BE CERTIFIED TO C.S.A. B.182.2
AND CONFORM TO A.S.T.M. F477

SEWER SERVICES - P.V.C. DR-28 CERTIFIED TO C.S.A. B.182.2 OR B182.4
AND CONFORM TO A.S.T.M. D3034 F679, F794 & F949.
SEALING GASKETS MUST BE CERTIFIED TO C.S.A. B.182.2
AND CONFORM TO A.S.T.M. F477

THE POSITION OF ALL STRUCTURES, ABOVE GROUND & BELOW GROUND MAY NOT BE SHOWN ON THE CONTRACT DRAWINGS & WHERE SHOWN MAY NOT BE AN ACCURATE LOCATION. THEREFORE BEFORE ANY CONSTRUCTION THE CONTRACTOR MUST VERIFY LOCATION & POSITION OF ALL SUCH UTILITIES & STRUCTURES.

LOCATION: HO.#35
FH-No.1154 T.O. NUT
EL. 328.382

METRIC METRIC UNITS
DISTANCES SHOWN ON THIS PLAN
ARE IN METRES AND CAN BE CONVERTED
TO FEET BY DIVIDING BY 0.3048

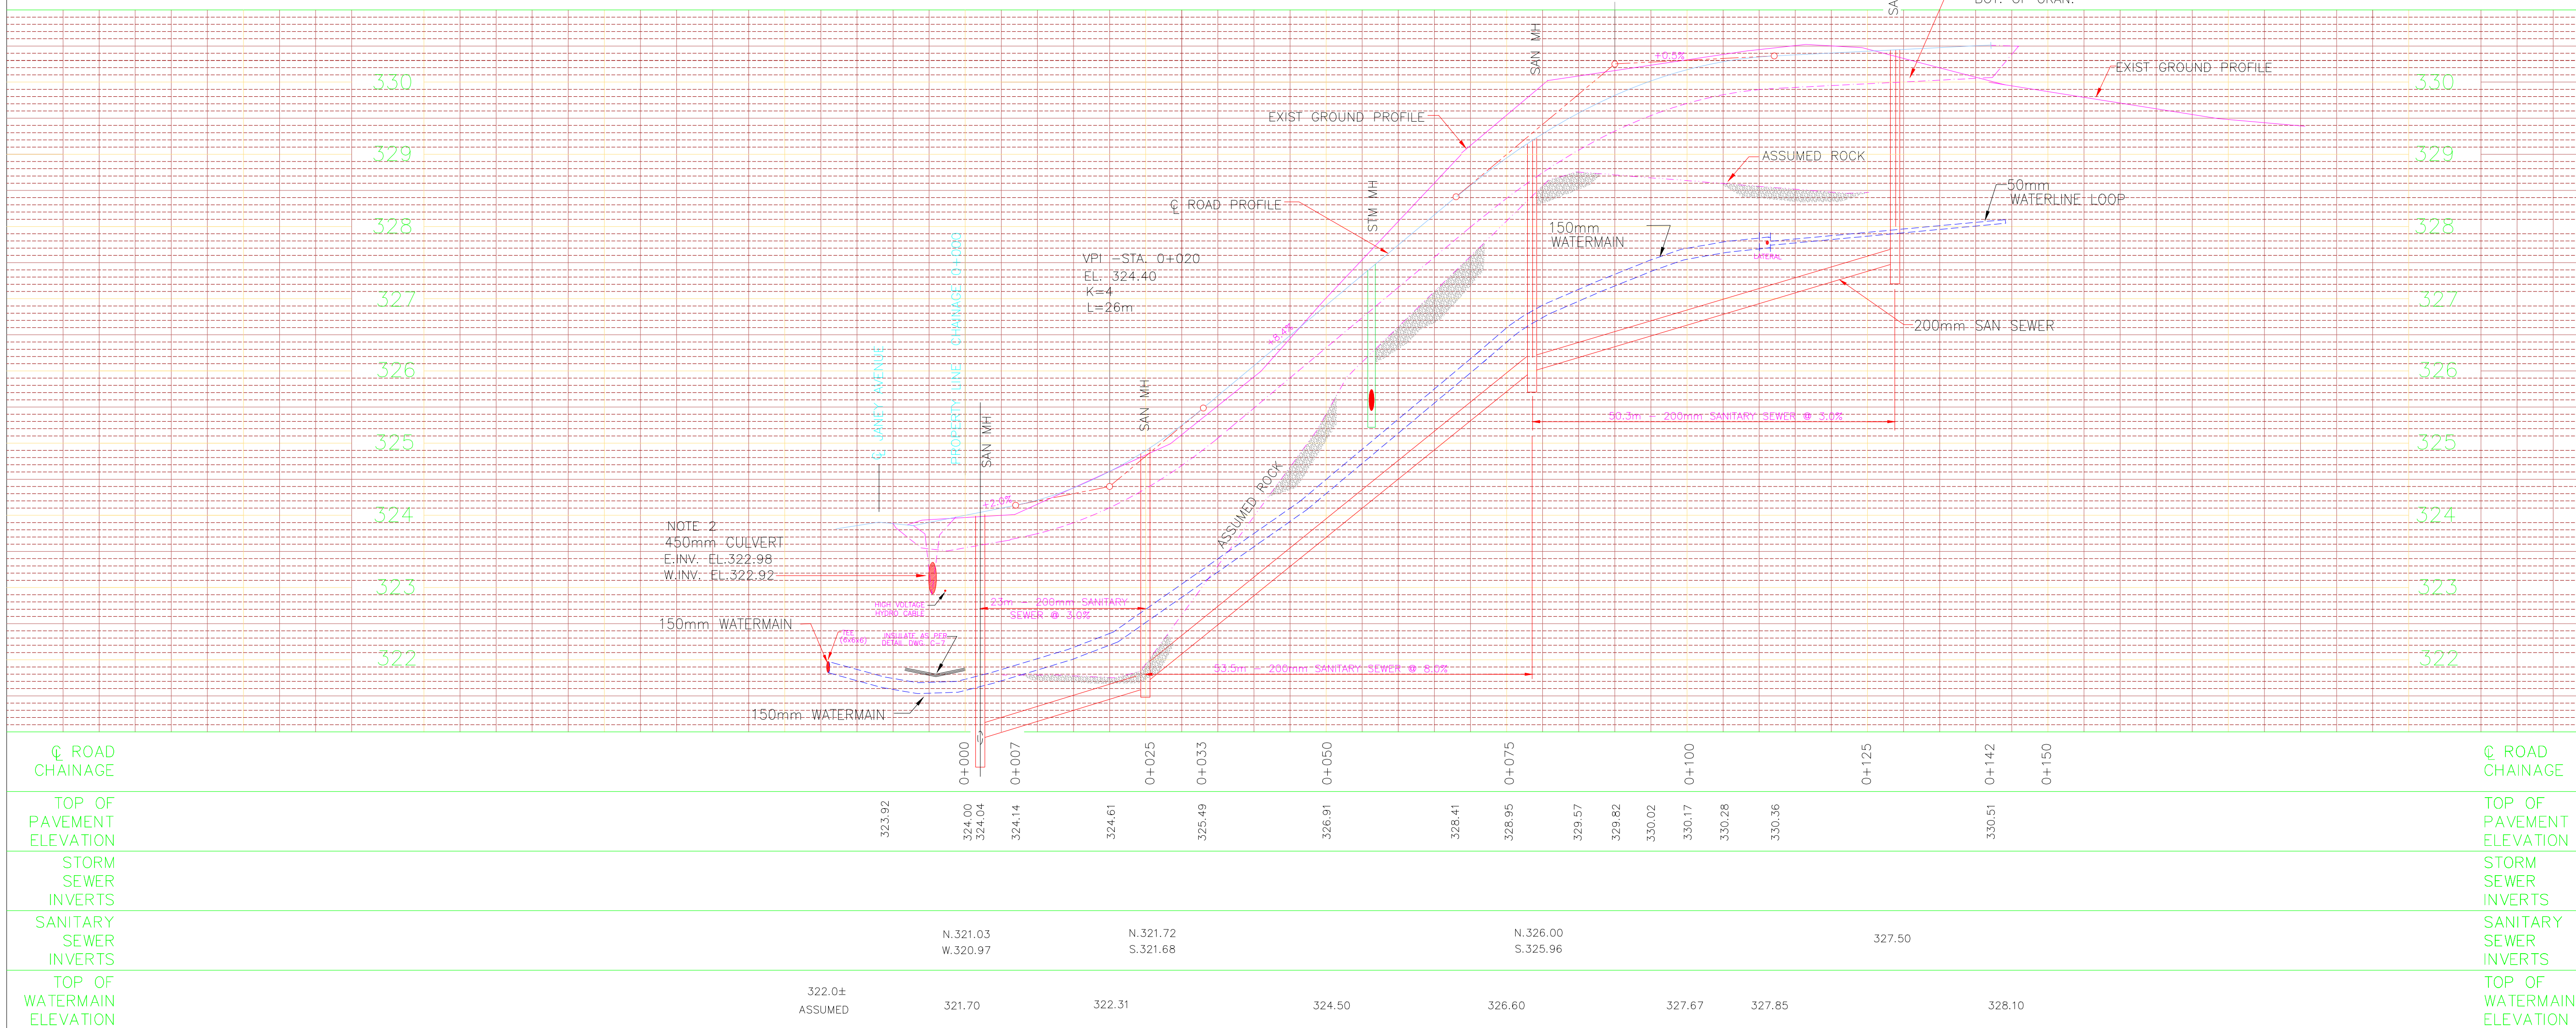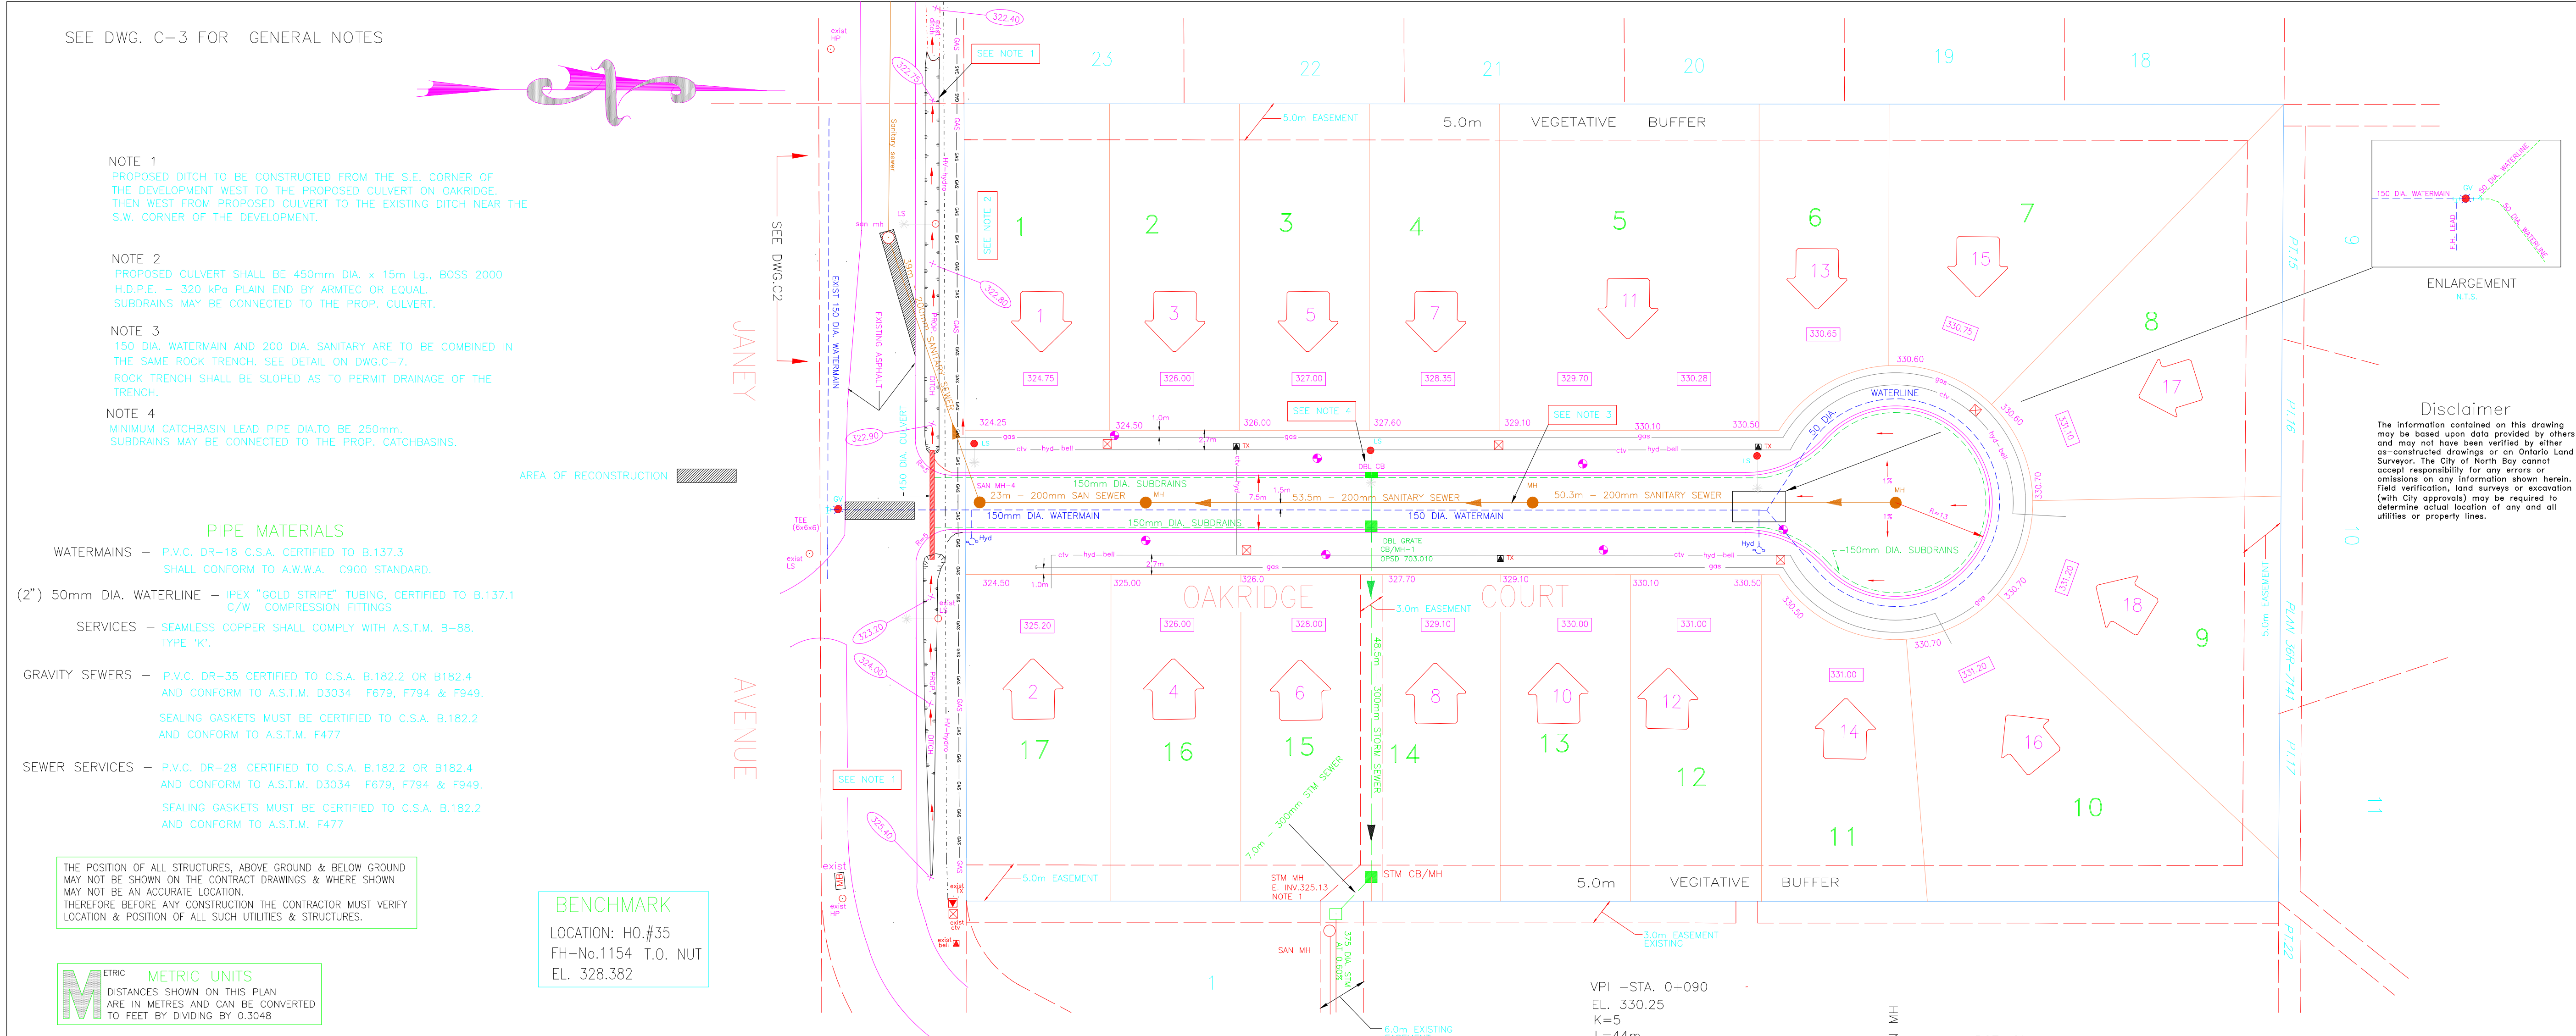

RECOMMENDED BY	APPROVED BY
----------------	-------------

CITY OF NORTH BAY
OAKRIDGE SUBDIVISION

873342 ONTARIO INC.

OAKRIDGE COURT

PLAN AND PROFILE

Miller & Urso Surveying Inc.
Project Managers ♦ Planning Consultants



1401 SEYMOUR STREET - UNIT 2
NORTH BAY, ON. M1B 6G4

TEL: (705) 474-1210
FAX: (705) 474-1783
E mail: rm.ds@an.aibn.ca

DRAWN BY:	G.L.Holmes	DATE:	APRIL/2002
-----------	------------	-------	------------

REVIEWED BY: T.A.Etches	SCALE:
CAD FILE	HORIZ 1 : 5

OFFICE	PROJECT No	DRAWING No
	00801	0.353