


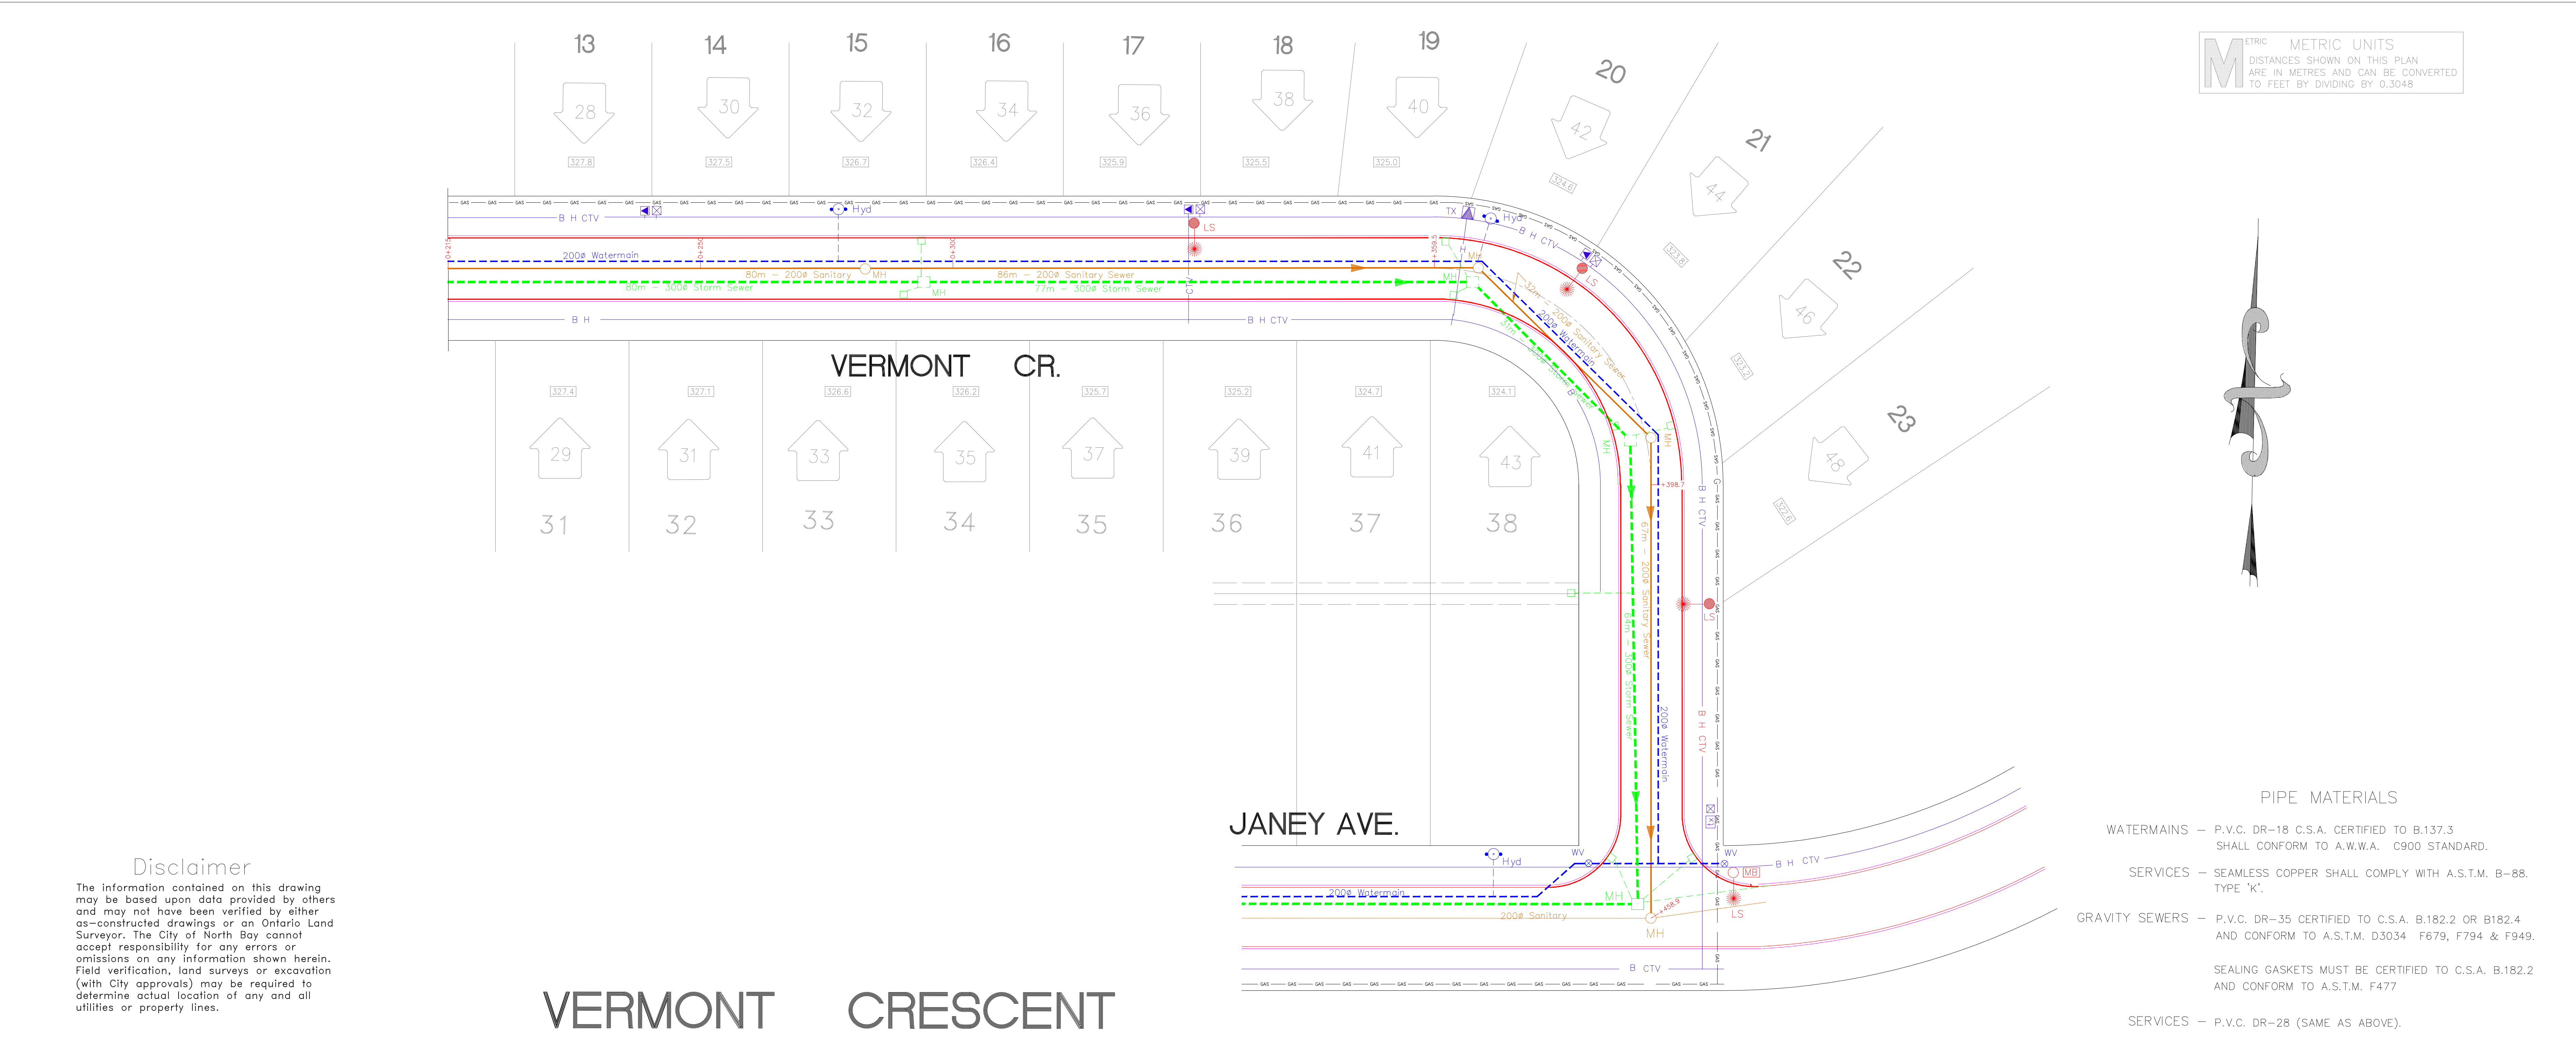

METRIC METRIC UNITS
DISTANCES SHOWN ON THIS PLAN
ARE IN METRES AND CAN BE CONVERTED
TO FEET BY DIVIDING BY 0.3048

REFERENCE			
DWG. No	DESCRIPTION		
C1	GENERAL PLAN		
C2	PLAN AND PROFILE		
C4	PLAN AND PROFILE		
C5	STANDARDS		
C6	STANDARDS		
C7	STANDARDS		
C8	STANDARDS		
C9	STANDARDS		

LEGEND

MIN. FINISHED GRADE AT HSE LOCATION

205.21

EXISTING WATERMAIN – GATE VALVE



PROP. WATERMAIN – GATE VALVE



PROPOSED FIRE HYDRANT



EXISTING FIRE HYDRANT



PROPOSED SANITARY MANHOLE



EXISTING SANITARY MANHOLE



PROPOSED STORM MANHOLE



EXISTING STORM MANHOLE



CATV PEDESTAL



HYDRO TRANSFORMER



BELL BOX



PROPOSED STREET LIGHT STANDARD



 
PROPOSED HOUSE NUMBERS FOR PHASE II



BOREHOLE (J.D.PATERSON-SEPT/2001)



EXISTING HOUSE NUMBERS FOR PHASE I



PROPOSED U/G HYDRO CABLE



PROPOSED U/G BELL CABLE



PROPOSED U/G T.V. CABLE



PROPOSED NATURAL GAS LINE



EXISTING UTILITIES



GAS PLANT APPROVED		CATV PLANT APPROVED	
UNION GAS	DATE	COGECO CABLE TV.	DATE
HYDRO PLANT APPROVED		BELL PLANT APPROVED	
NORTH BAY HYDRO	DATE	BELL CANADA LTD.	DATE

GLH	ADDED EXTRA BOREHOLE DATA	OCT 11/2001	1	
GLH	PRELIMINARY FOR REVIEW	SEPT/2000	0	
APP'D BY	DETAILS	DATE	No	
REVISIONS				

